




DRAWING TITLE :
SINGLE LINE DIAGRAM FOR
FEEDER PILLAR 1

PROJECT TITLE :
PEMASANGAN ELEKTRIK UNTUK
PROJEK BAIKPUH KEROSAKAN
BANGUNAN DAN KERJA-KERJA
BERKAITAN DI SEKOLAH MENENGAH
SAINS MIRI, SARAWAK.


ELECTRICAL CONTRACTOR :
SINARJATI SINARJAYA ELEKTRIK
NO. 77 JALAN SG 3/1,
PUSAT BANDAR SERI GOMBAK,
68100 BATU CAVES,
SELANGOR DARUL EHSAN.
TEL: 03-6186 4392 & 6186 4393
FAX: 03-6186 4394
EMAIL: sinar_jaya@yahoo.com

DRAWING TITLE : SINGLE LINE DIAGRAM FOR SSB-B5 (BLOK SENIOR)		(SHOP DRAWING)	
DRAWN BY : AZLAN	DATE : 15-05-12		
CHECKED BY : H+S	SCALE : N.T.S		
DRAWING NO. : CS/YC/121/02B/S/SMS/SI.NAR -0070	REV.		
	01		

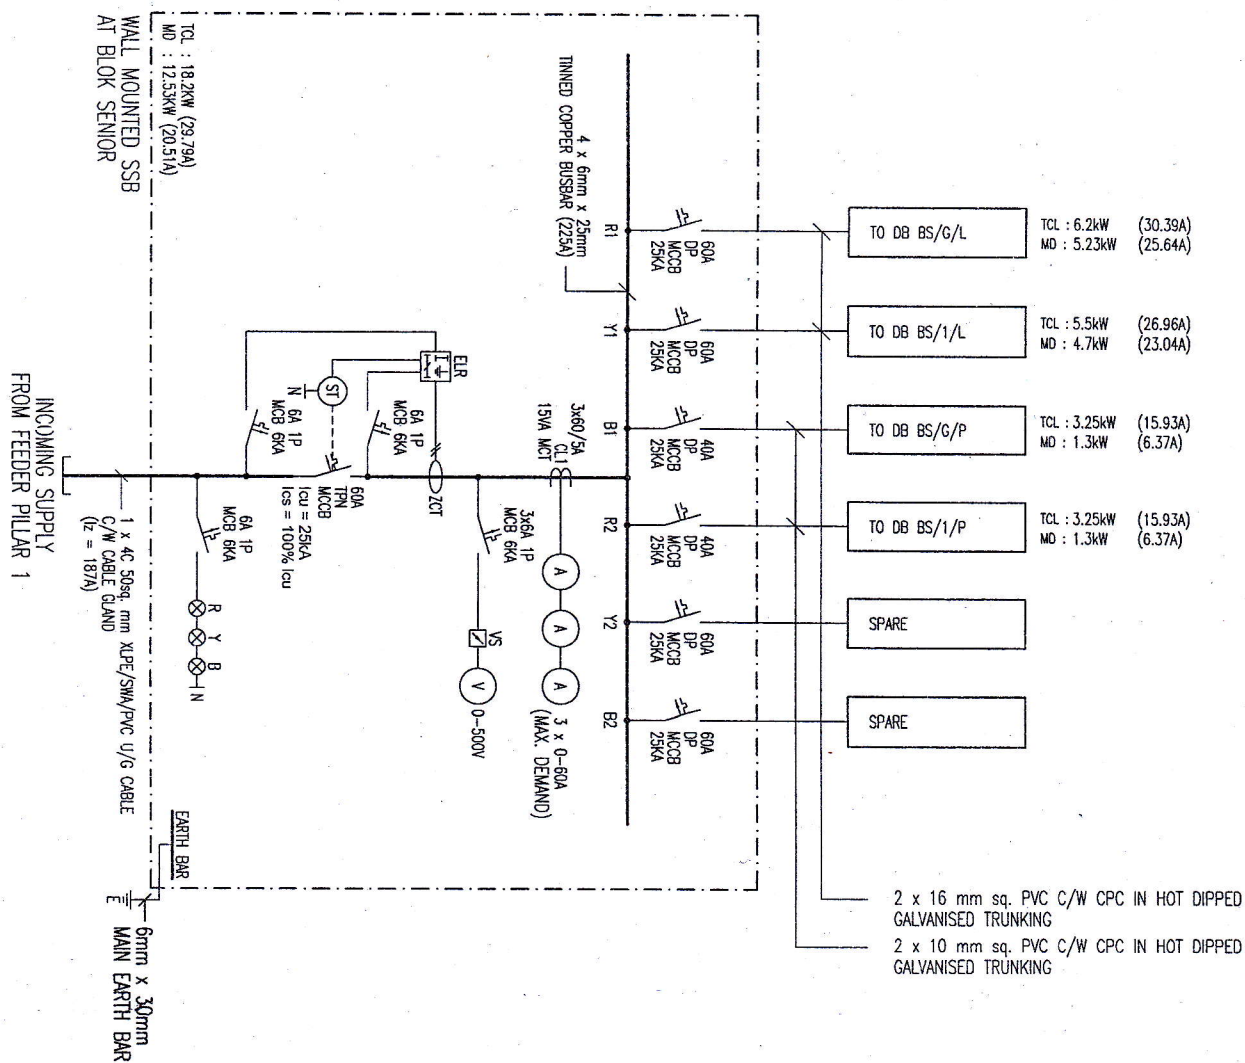

MD WATT (AMPs)	1.3kW (6.37Amp)							
DIVERSITY FACTOR	0.4							
TCL WATT (AMPs)	3.25kW (15.93Amp)							
CL (W)	1000	1000	750	500	SPARE	SPARE	SPARE	SPARE
2 x 13A S/S/O								
13A S/S/O (Computer)	4	4	3	1				
CIRCUIT NO.	1	2	3	4	5	6	7	8

2 x 4mm.sq PVC C/W CPC
IN SURFACE G.I CONDUIT

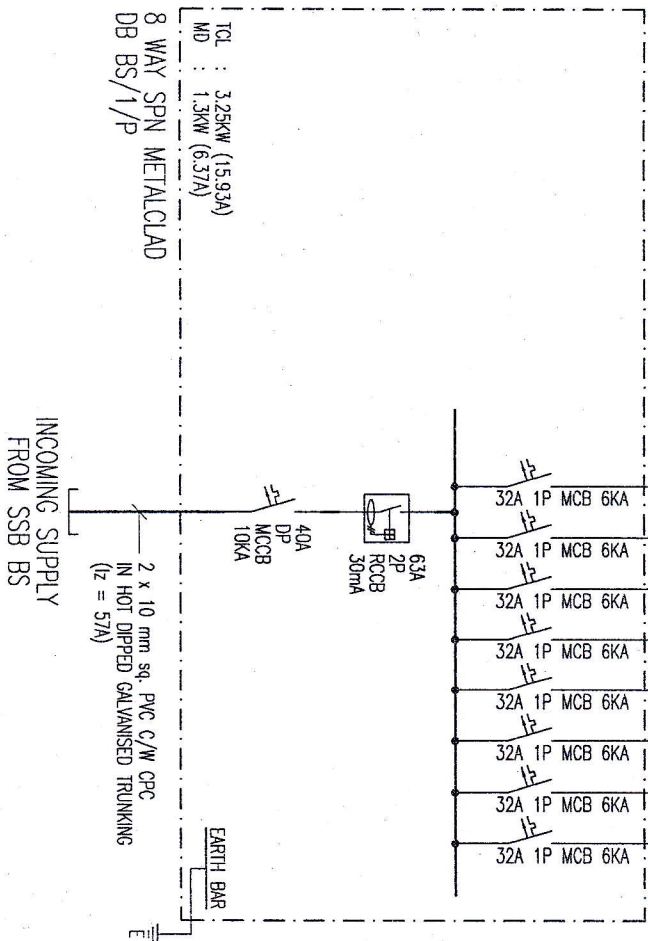

TCL : 3.25kW (15.93A)
MD : 1.3kW (6.37A)

8 WAY SPN METALCLAD
DB BS/1/P

REV.	DESCRIPTION	DATE

PROJECT TITLE :
PEMASANGAN ELEKTRIK UNTUK
PROJEK BAKPUH KEROSAKAN
BANGUNAN DAN KERJA-KERJA
BERKAITAN DI SEKOLAH MENENGAH
SAINS MIRI, SARAWAK.

CONSULTANT :



CAMWANGAN KAJANGAN ELEKTRIK
BUKALAMPUR
KUALA LUMPUR

ELECTRICAL CONTRACTOR :

SYARIKAT SINARJAYA ELEKTRIK
NO: 77 JALAN SG 3/1,
PUSAT BANDAR SERI GOMBAK,
48100 BATU CAVES,
JELANGOR DARUL EHSAN.
TEL: 03-6186 4392 & 6186 4393
FAX: 03-6186 4394
EMAIL: sinar_jaya@yahoo.com

SWITCHBOARD MANUFACTURER :

CENTRAL SWITCHGEAR SDN BHD
(1037984-H)
LOT 9480 WEST ROAD,
JINJANG NORTH INDUSTRIAL ESTATE,
52000 KUALA LUMPUR.
TEL: 03-6253 1176 & 6253 2475
FAX: 03-6253 1179
EMAIL: indochdome@hotmail.com

DRAWING TITLE :

SINGLE LINE DIAGRAM FOR
DB BS/1/P

DRAWN BY :	AZLAN	DATE :	31-03-12	REV.	01
CHECKED BY :	H.S	SCALE :	N.T.S		
DRAWING NO. :	CS/VC/12/1028/SMSWS/SINAR - 038d				